


3.4 Attachment A - Section 3 Process Flow Diagram



 SEAFT & ASSOCIATES, INC. 2808 South 18th Street, Suite B Tampa, FL 33619	DRAWING TITLE	PROCESS DESIGN
	PROJECT TITLE	OILY WATER PROCESSING FACILITY
CLIENT	UNIVERSAL ENVIRONMENTAL SOLUTIONS, LLC 1650 HEMLOCK AVE TAMPA, FL 33605	DESIGNED BY K.C. CERTIFICATE OF AUTHORIZATION NO. 0528 PHONE (813)917-9267 FAX (813)830-1607
BY	REVISIONS	CHECKED BY J.S. DATE 9-28-18 SCALE AS SHOWN PROJECT NO. 3119.001.001
		Figure 3.4

3.4 Attachment B – Section 3 Dynalene Ionic Exchange System Design Diagram

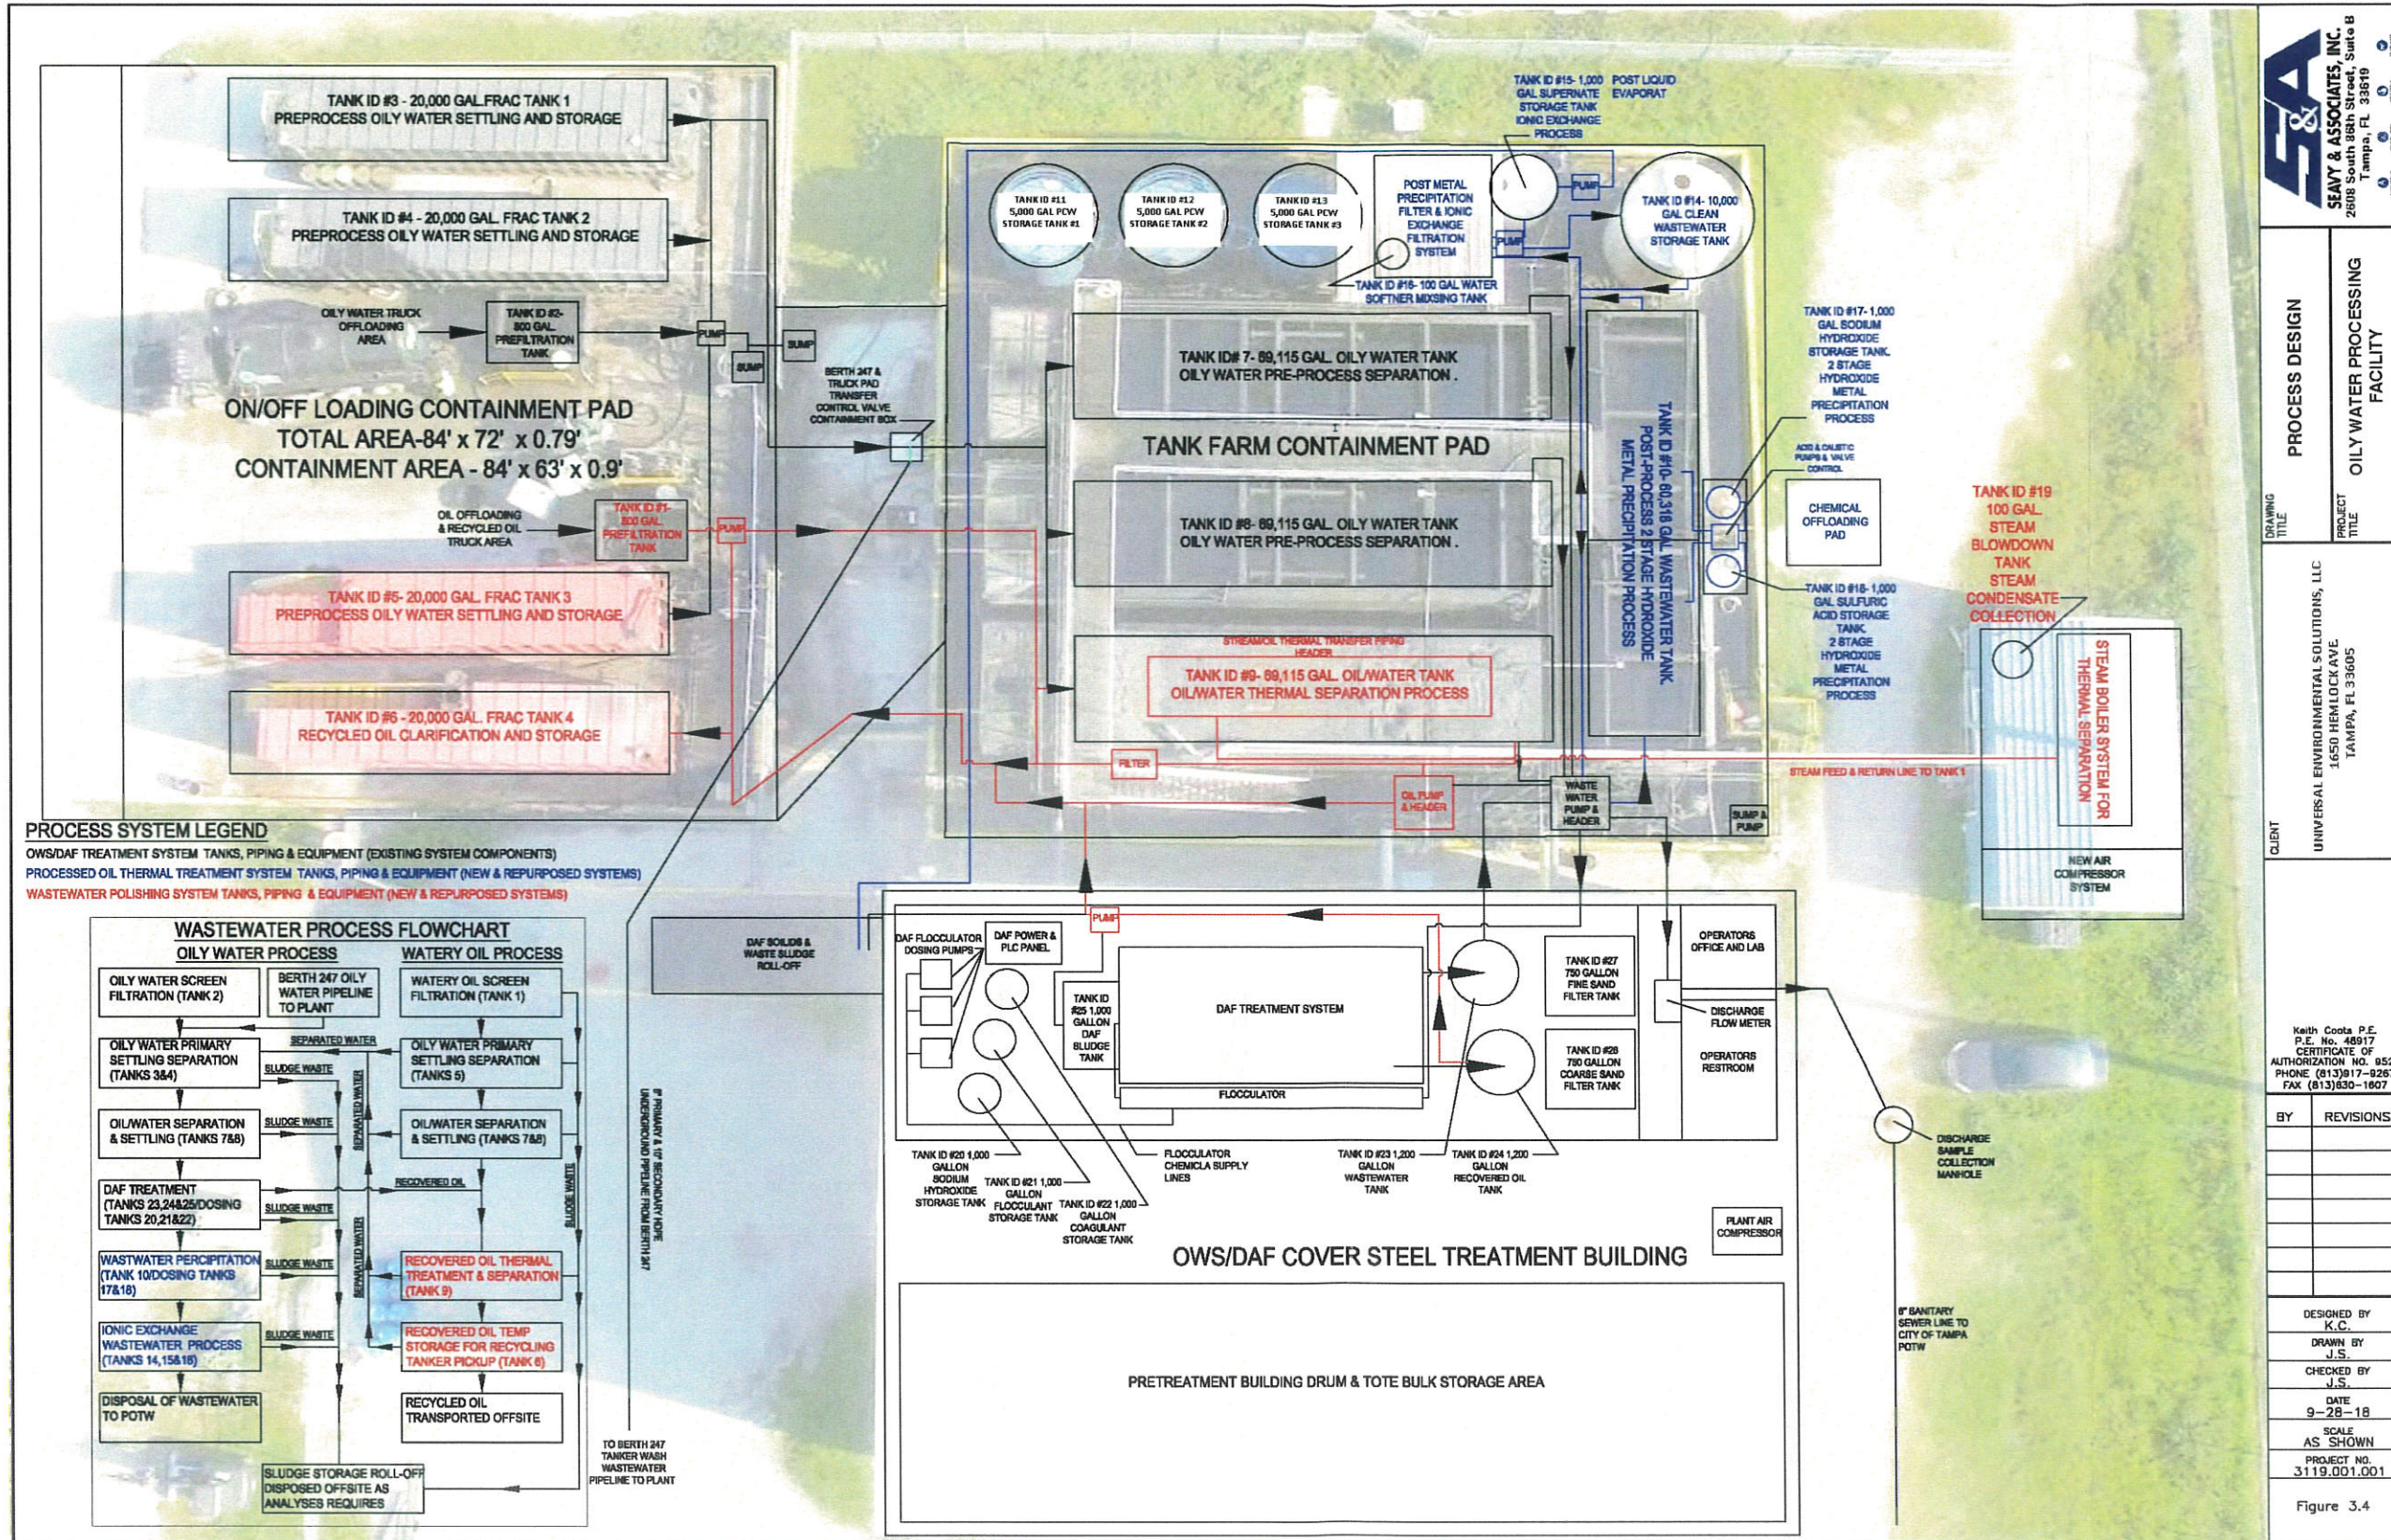